



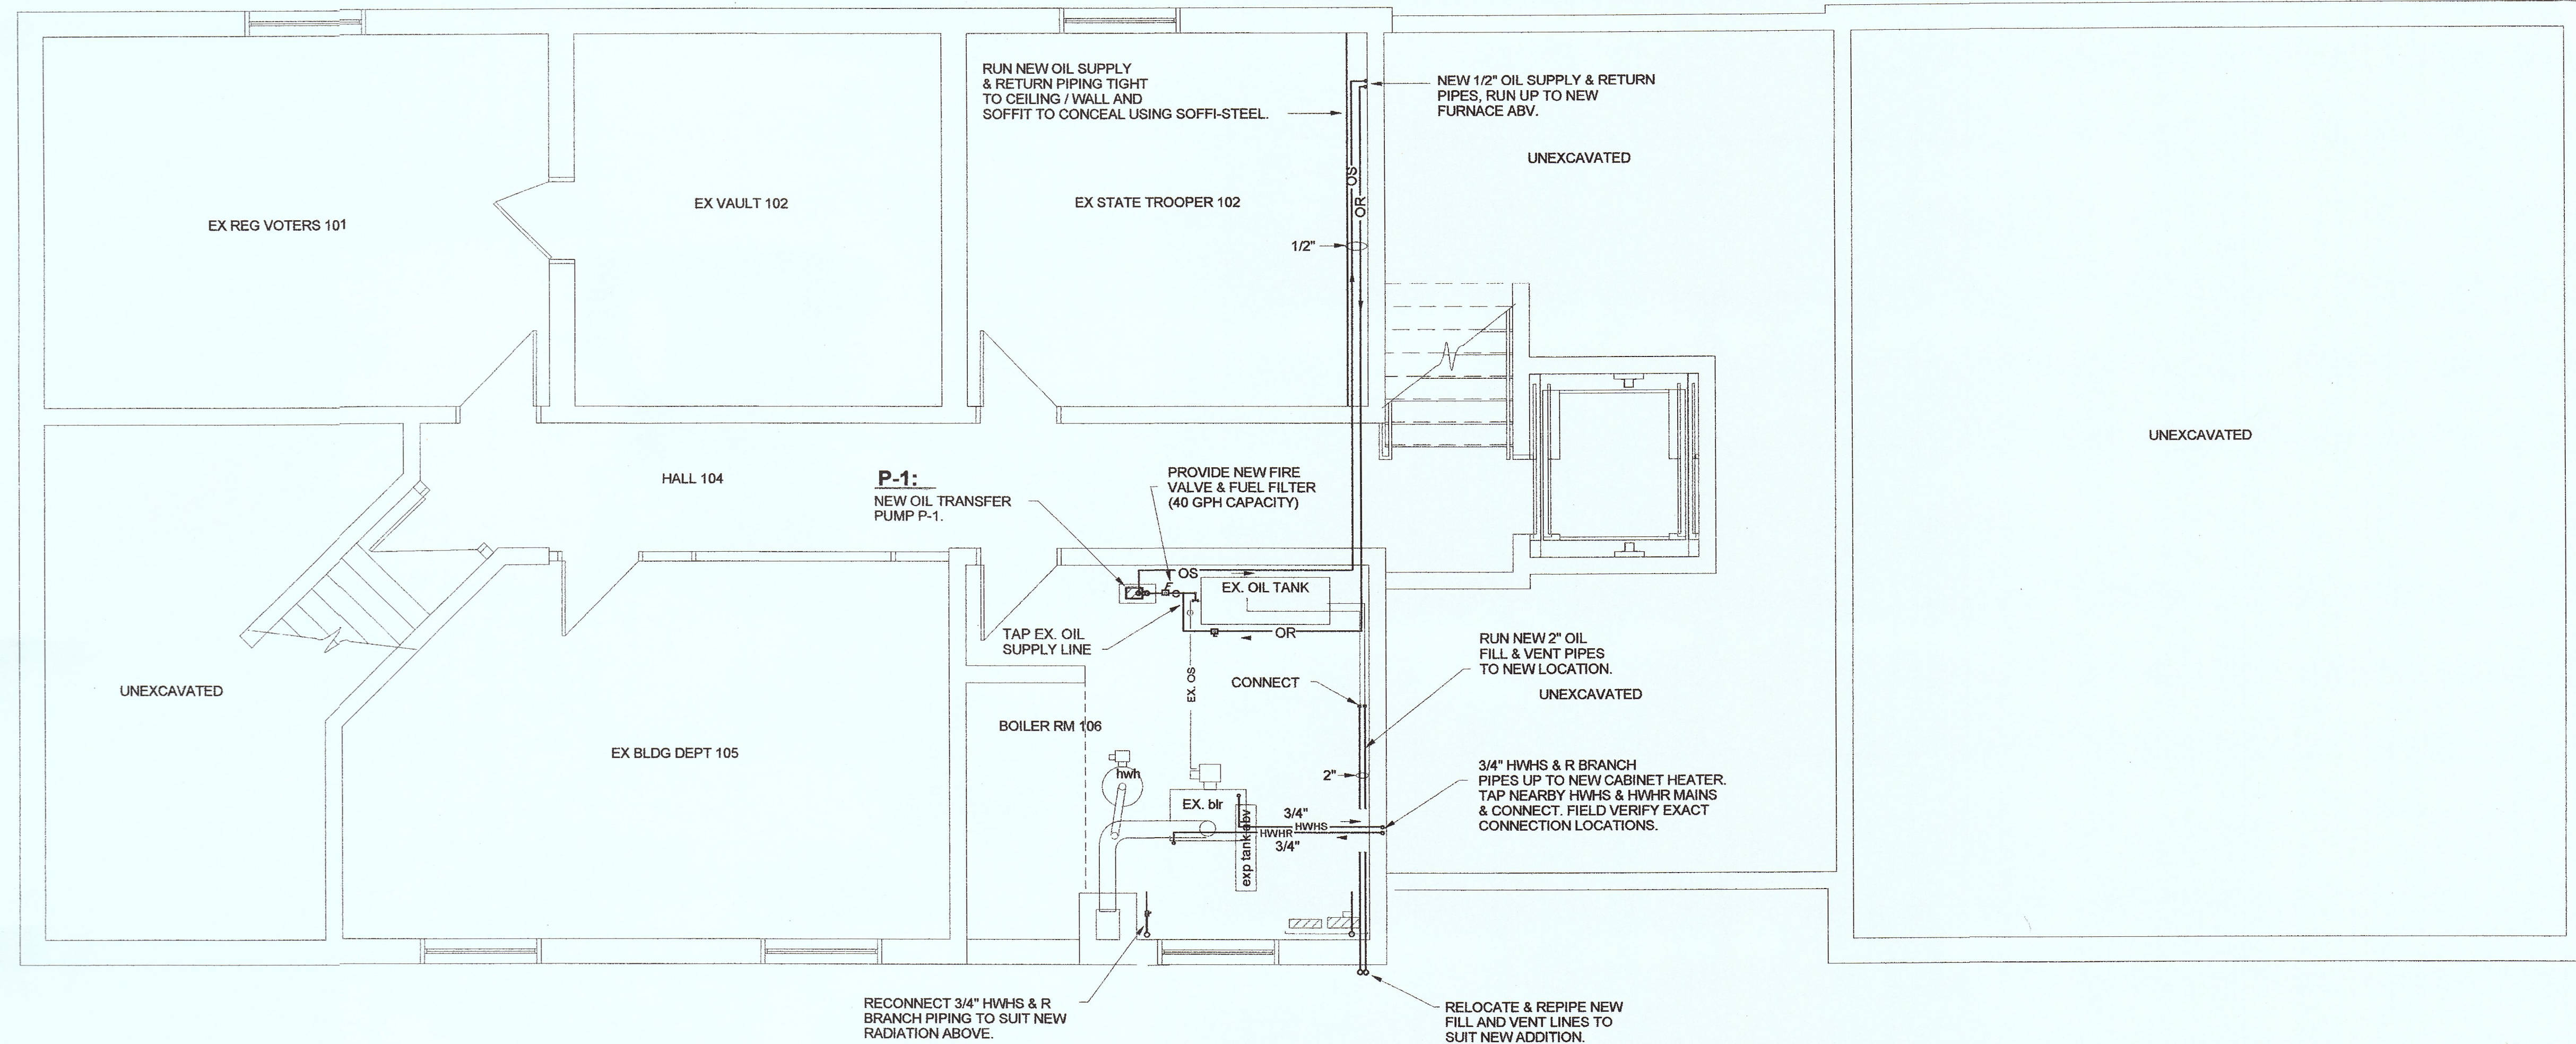


LOWER LEVEL PLAN- NEW WORK

SCALE = 1/4" = 1'-0"

LEGEND	
	THERMOSTAT
	NEW PRE-INSULATED FLEX SUPPLY DUCT
	SUPPLY DIFFUSER WITH OBD
	CEILING RETURN REGISTER OR GRILLE
	SUPPLY DUCT
	RETURN DUCT
	EXHAUST DUCT
	FRESH AIR SUPPLY DUCT
	MOTORIZED CONTROL DAMPER
	VOLUME DAMPER
	FIRE DAMPER
	OIL SUPPLY PIPE
	OIL RETURN PIPE
	FIRE VALVE

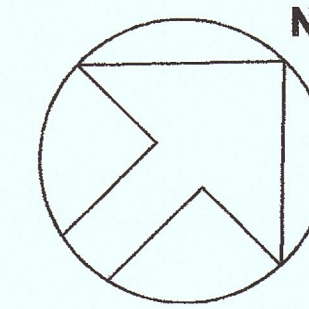

NORTH

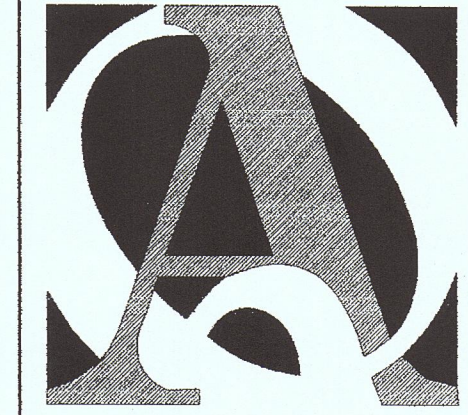

QUISENBERRY ARCARI
ARCHITECTS, LLC

qa-architects.com
T (860) 677-4594
F (860) 677-8534

318 Main Street
Farmington, CT 06032



ME
422 Highland Ave. Cheshire, CT 06410
203-271-3787

ADDITIONS & RENOVATIONS FOR:
ANDOVER TOWN HALL
17 SCHOOL ROAD
ANDOVER, CT

Sheet Description:

**LOWER LEVEL
FLOOR PLAN**

MECHANICAL

Scale:
1/4" = 1'-0"

Issue Date:
APRIL 2006

Project #:
QA 0585
MED 0624

Drawn By:
STD/NHS

Sheet #:

M1.0